



2019  
CITY OF STURGEON BAY  
GEORGIA ST

## LOCATION MAP

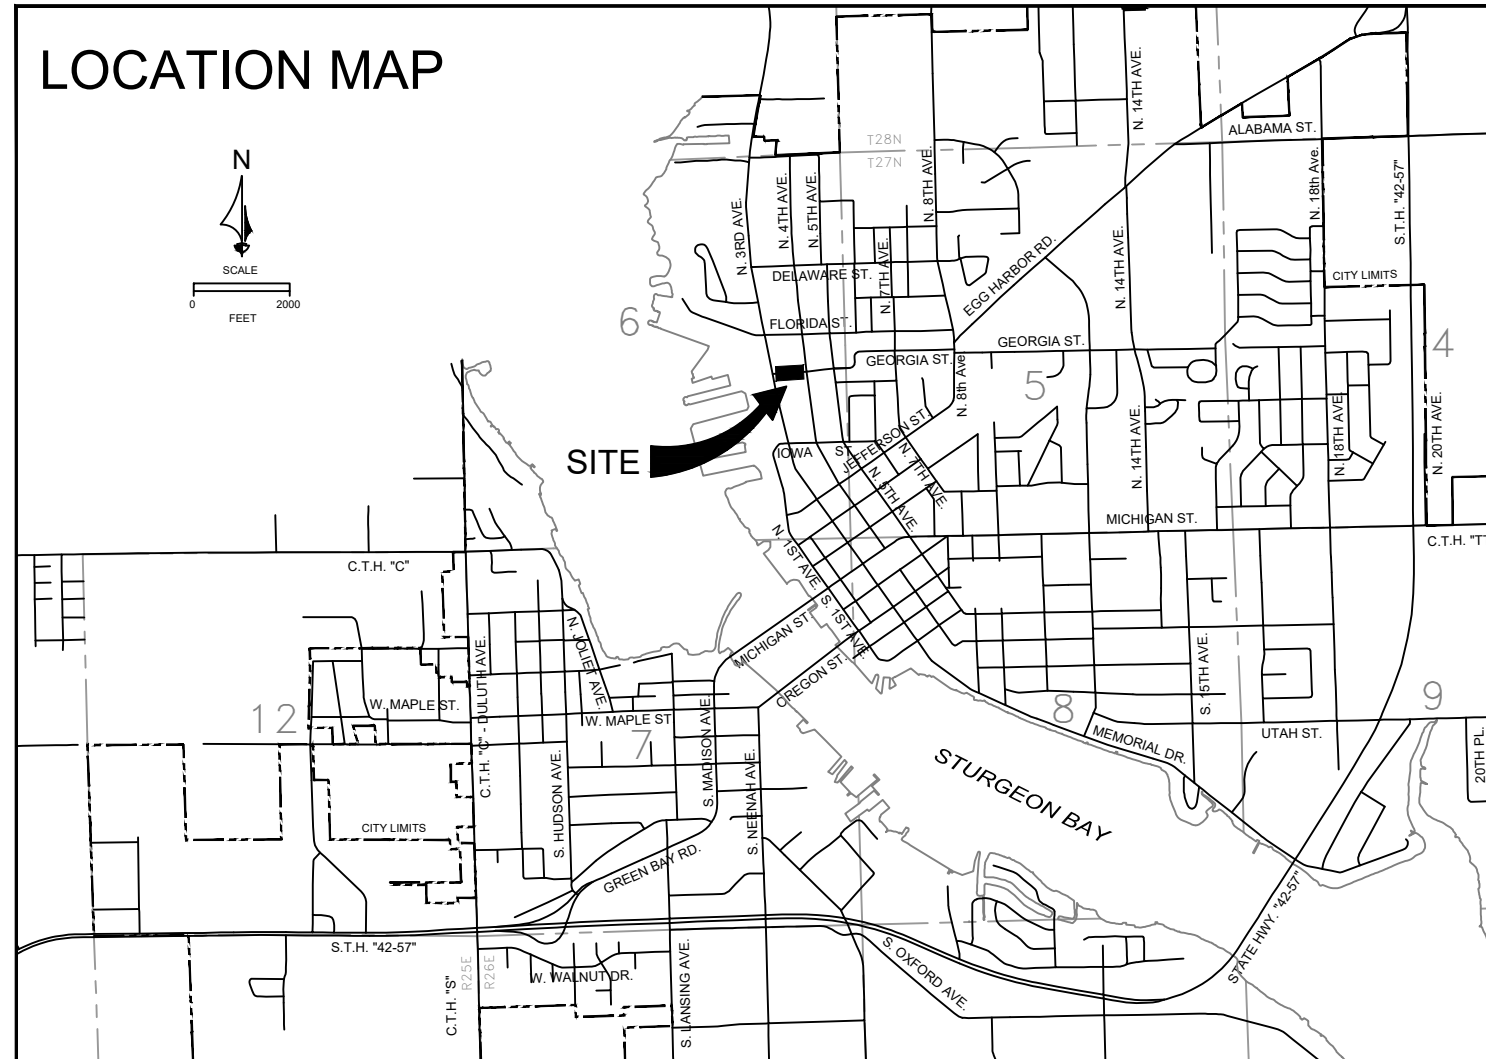

ABBREVIATIONS:

MH	SANITARY MANHOLE
SAN	SANITARY SEWER
WAT	WATER LINE
WV	WATER VALVE
GV	GATE VALVE
WS	WATER SERVICE
CS	CURB STOP
DI	DUCTILE IRON
CI	CAST IRON
PVC	POLYVINYL CHLORIDE
TRA	TRANSITE
CONC	CONCRETE
CB	CATCH BASIN
ST	STORM SEWER
STMH	STORM MANHOLE
INL	STORM INLET
UP	UTILITY POLE
T	TELEPHONE LINE
GAS	GAS LINE
GAS VLV	GAS VALVE
REM	REMOVE
SW	SIDEWALK
C-L	CENTERLINE
F-L	FLOW LINE
ABAND	ABANDON

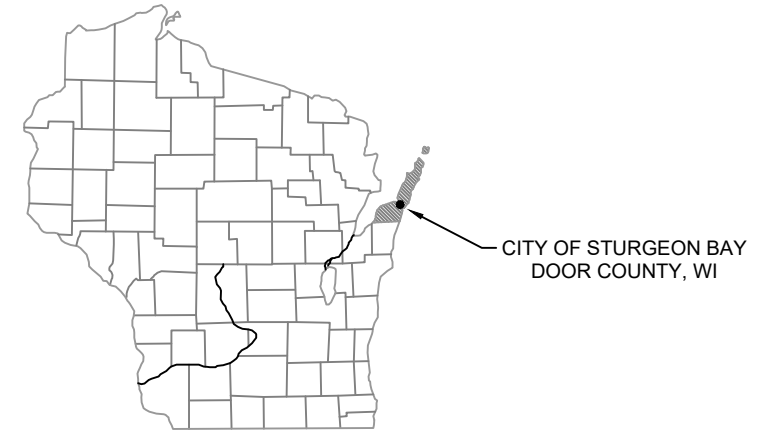





# INDEX



SHEET NO.

- |   |  |
|---|--|
| 1 | TRAFFIC CONTROL & EROSION CONTROL                  |
| 2 | PLAN & PROFILE                                     |
| 3 | SANITARY SEWER & WATER DETAILS                     |
| 4 | CURB, SIDEWALK, DRIVEWAY & TYPICAL SECTION DETAILS |

# TRAFFIC CONTROL & INLET PROTETION

## LEGEND


-  SIGN
-  TYPE "III" BARRICADE  
(TYPE "A" LOW INTENISTY  
FLASHING WARNING LIGHT(S)  
REQUIRED FOR NIGHTTIME USE)
-  INLET PROTECTION
-  WORK AREA

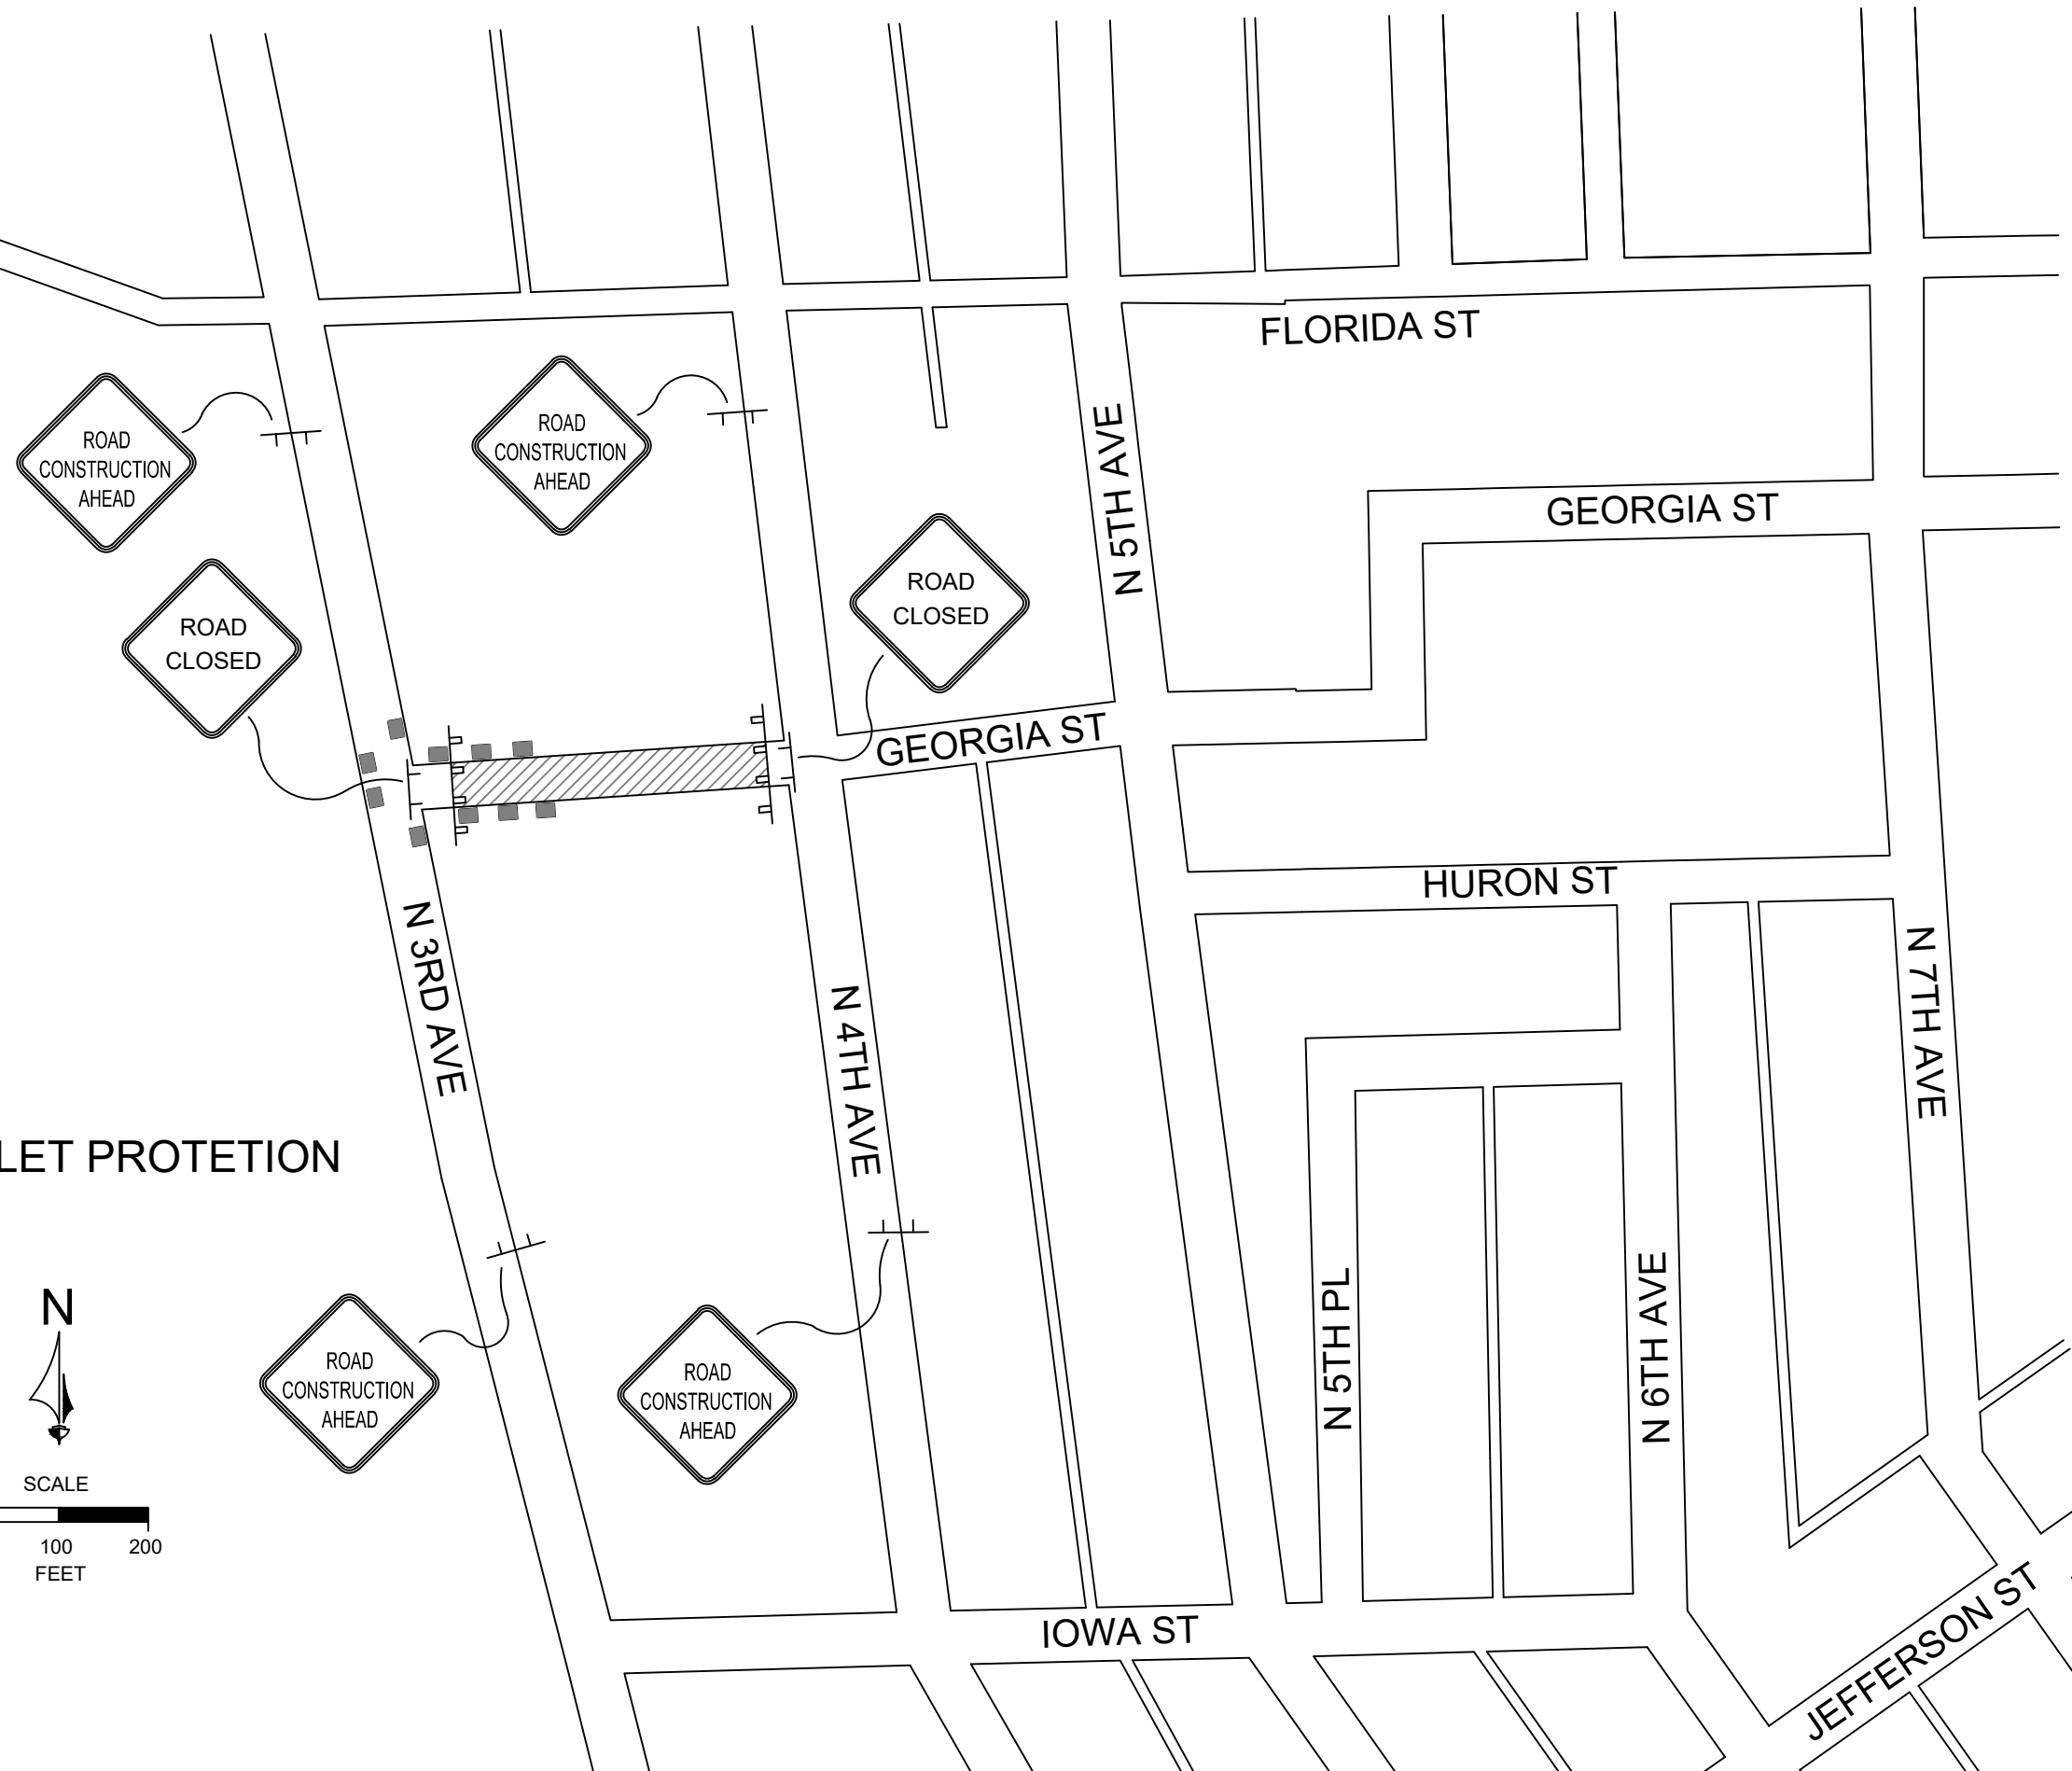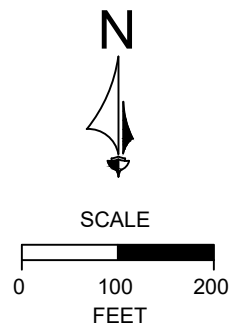


NOTES:

1. WATER LATERALS SHALL BE 1" COPPER, AND SANITARY LATERALS SHALL BE 6" PVC SCH 40. ALL WATER AND SEWER LATERALS SHALL BE INSULATED WITH 24" WIDE, 2" POLYSTYRENE.
2. NO GAPS OR SEQUENCING NEEDED DURING CURB INSTALLATION. ALL CURBING CAN BE INSTALLED AT THE SAME TIME.
3. ALL EXISTING STORM PIPING, MANHOLES & INLETS TO REMAIN IN PLACE.

NOTE:  
THE UTILITIES SHOWN IN PLAN AND PROFILE ARE INDICATED IN ACCORDANCE WITH AVAILABLE RECORDS. THE CONTRACTOR SHALL BE RESPONSIBLE FOR OBTAINING EXACT LOCATIONS AND ELEVATIONS OF ALL UTILITIES FROM THE OWNERS OF THE RESPECTIVE UTILITIES. ALL UTILITIES SHALL BE NOTIFIED 72 HRS. PRIOR TO EXCAVATION.

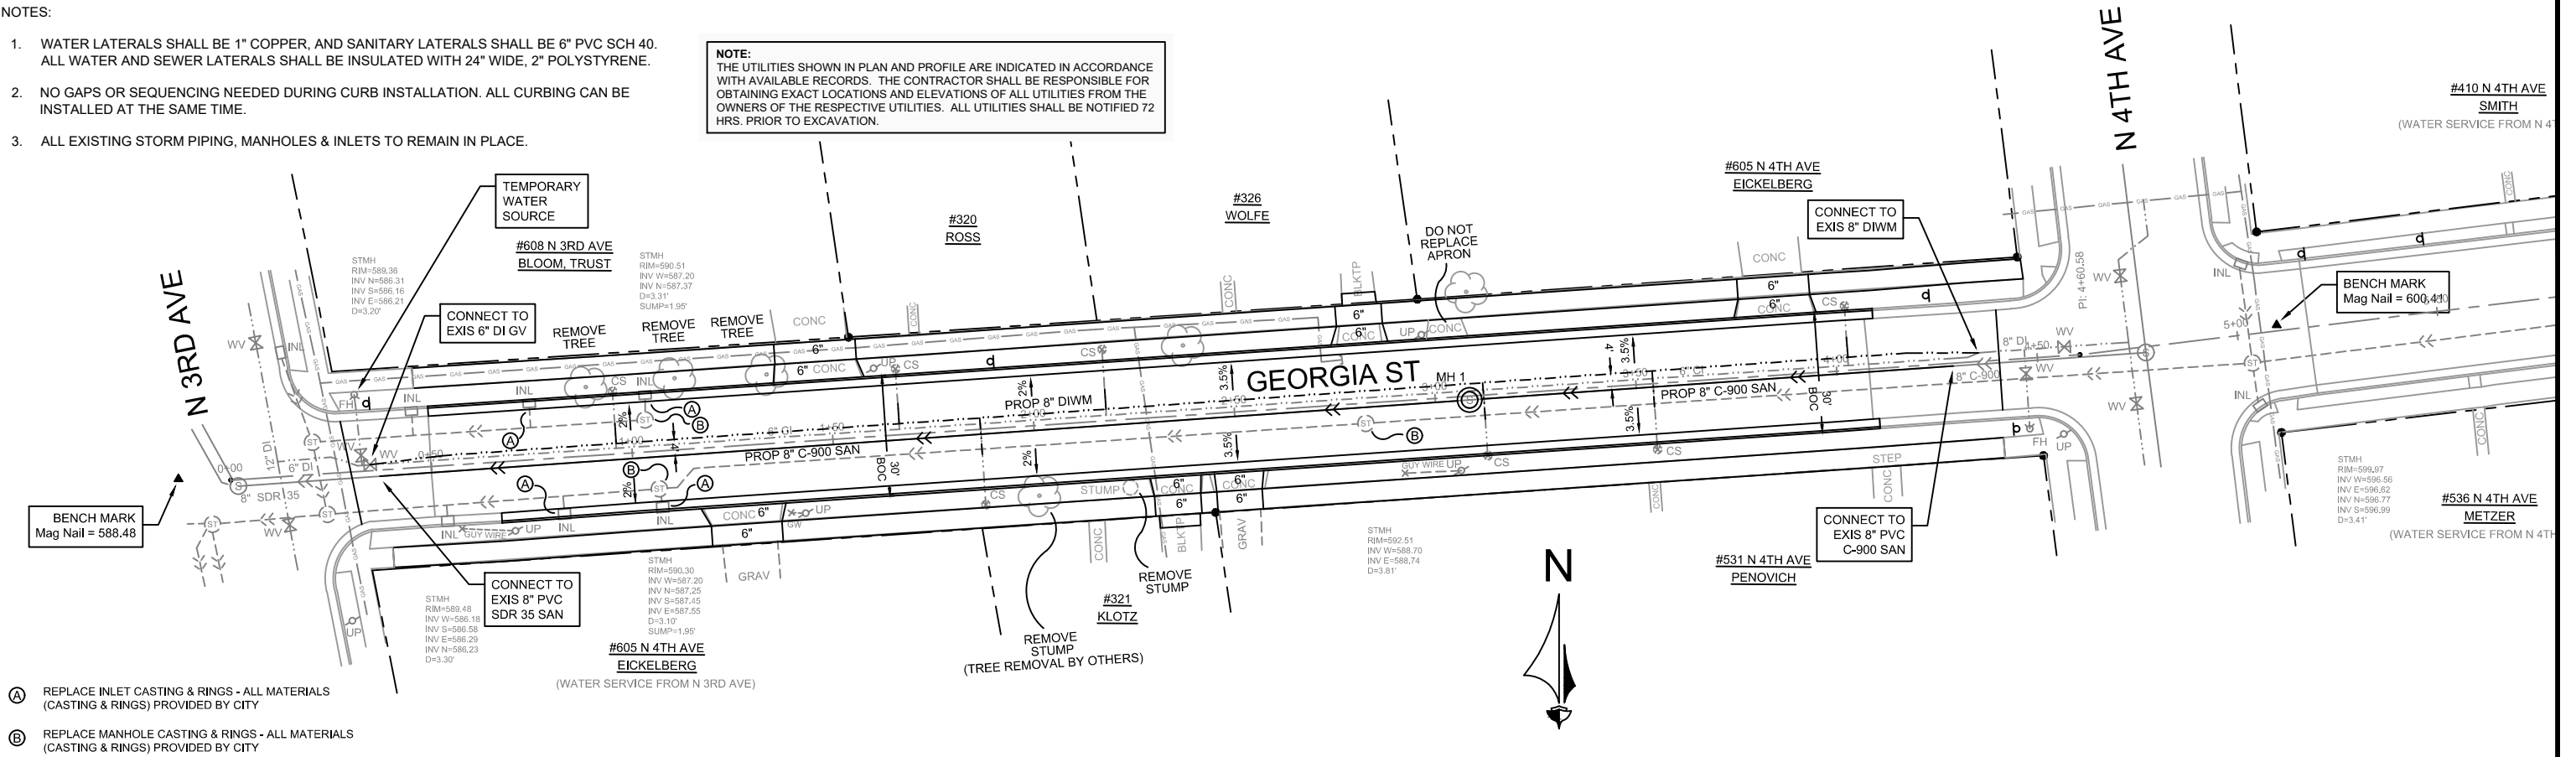




- (A) REPLACE INLET CASTING & RINGS - ALL MATERIALS (CASTING & RINGS) PROVIDED BY CITY
- (B) REPLACE MANHOLE CASTING & RINGS - ALL MATERIALS (CASTING & RINGS) PROVIDED BY CITY

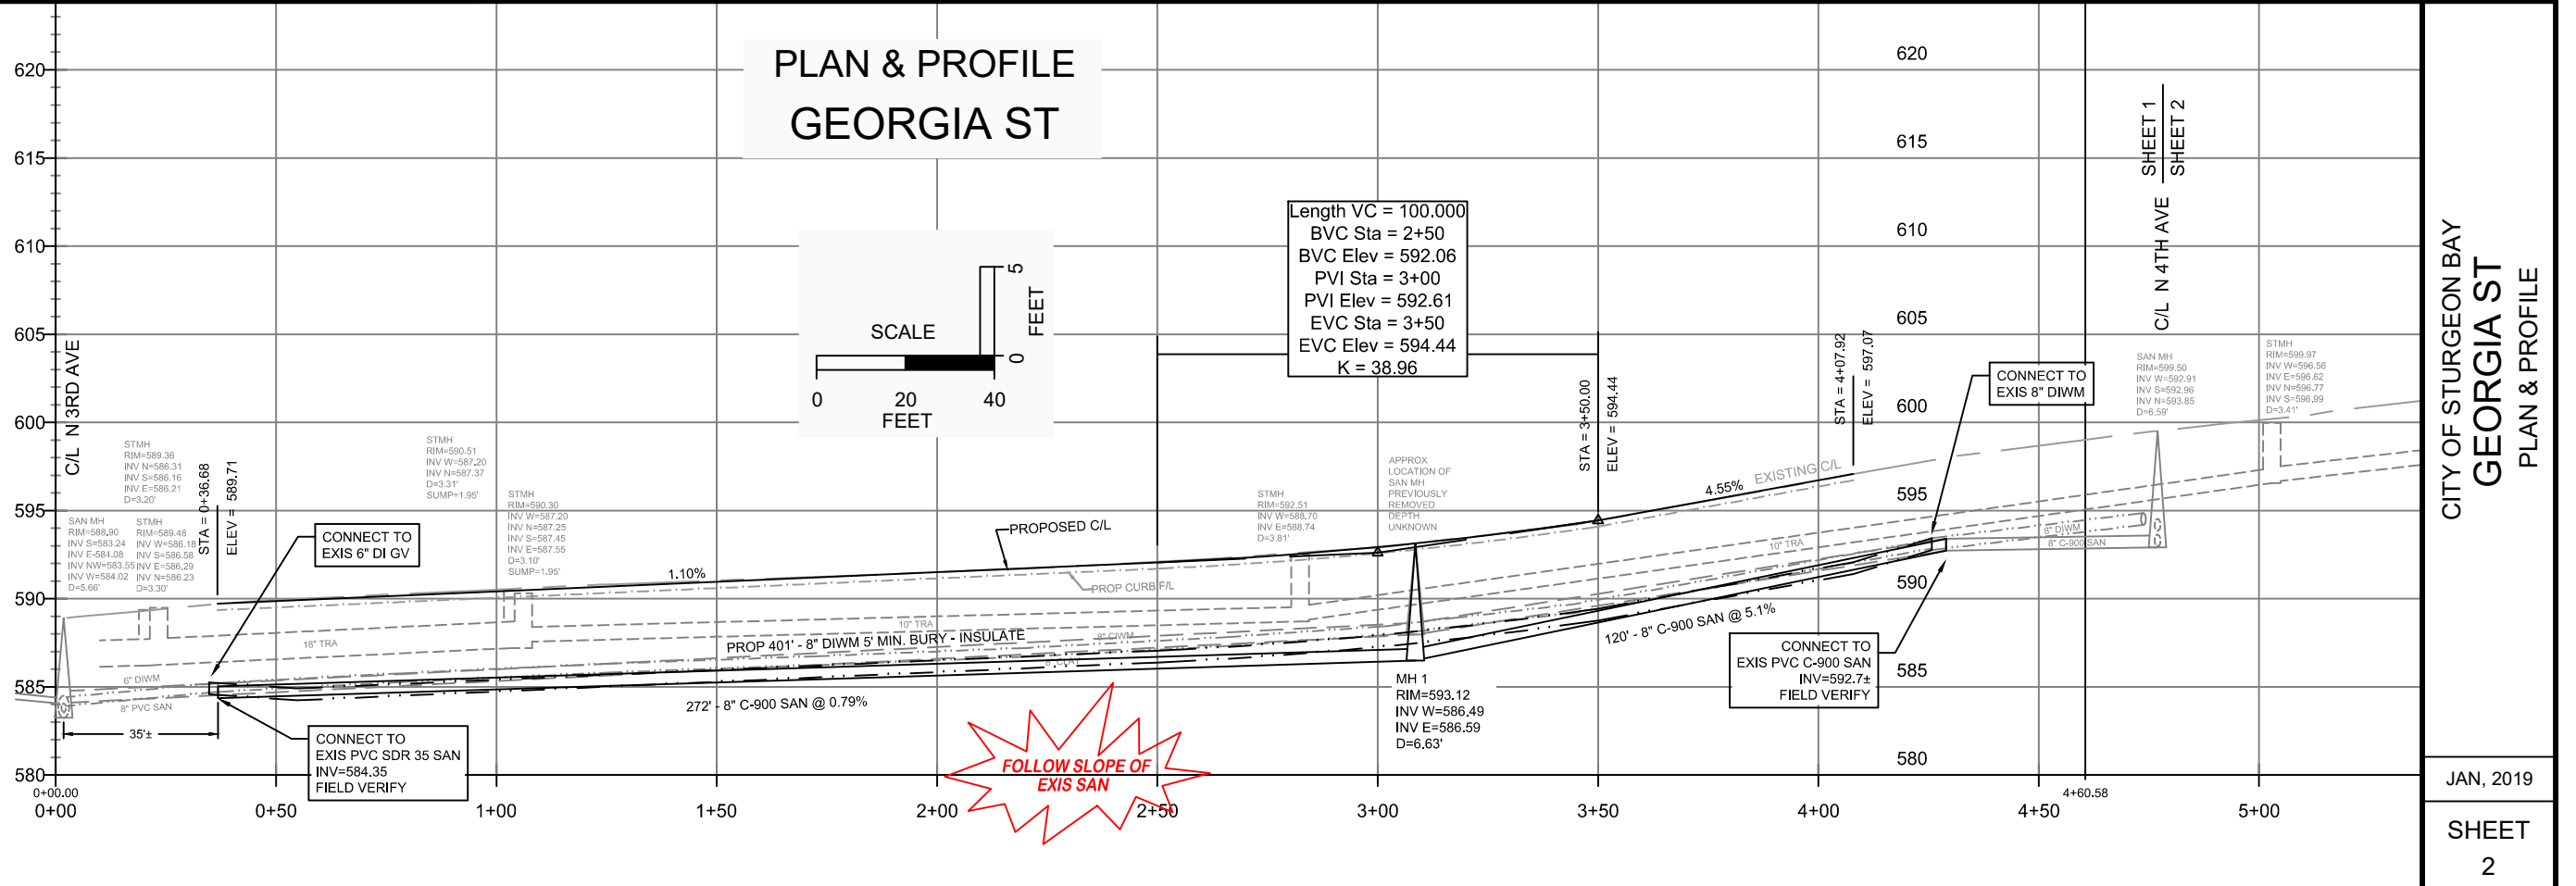


CITY OF STURGEON BAY  
GEORGIA ST  
PLAN & PROFILE

JAN, 2019


SHEET  
2

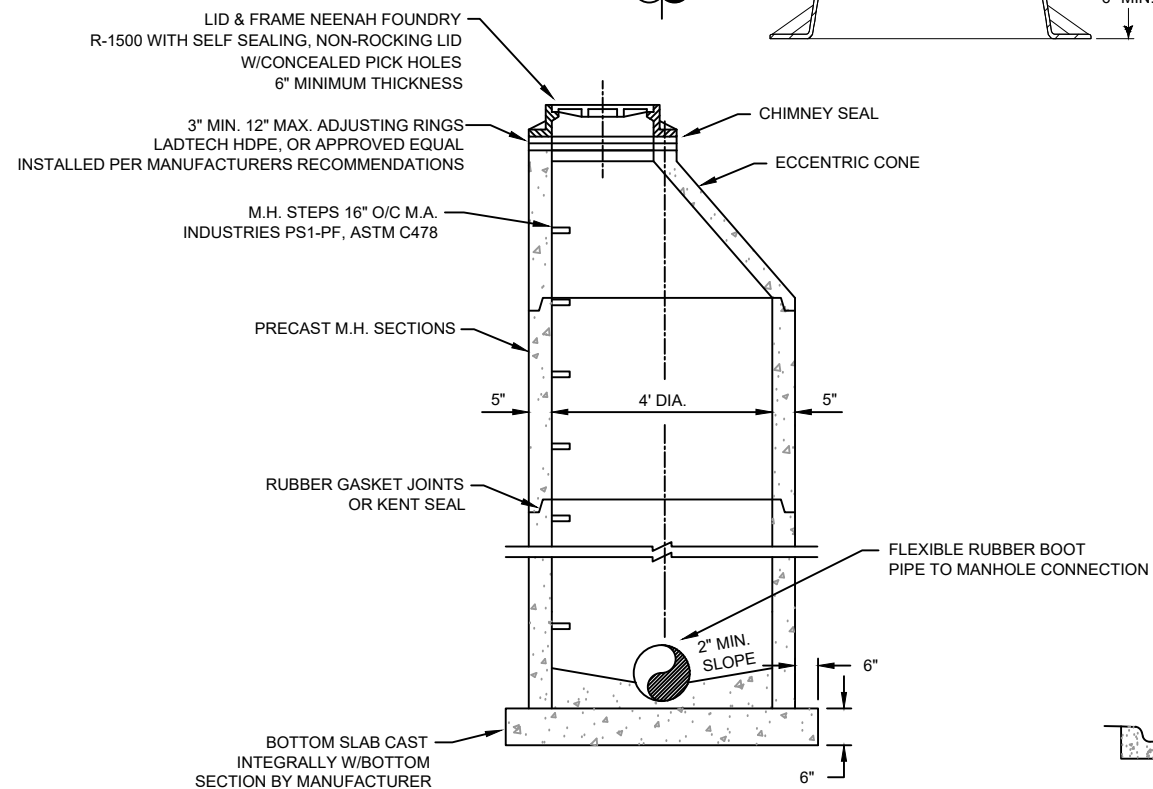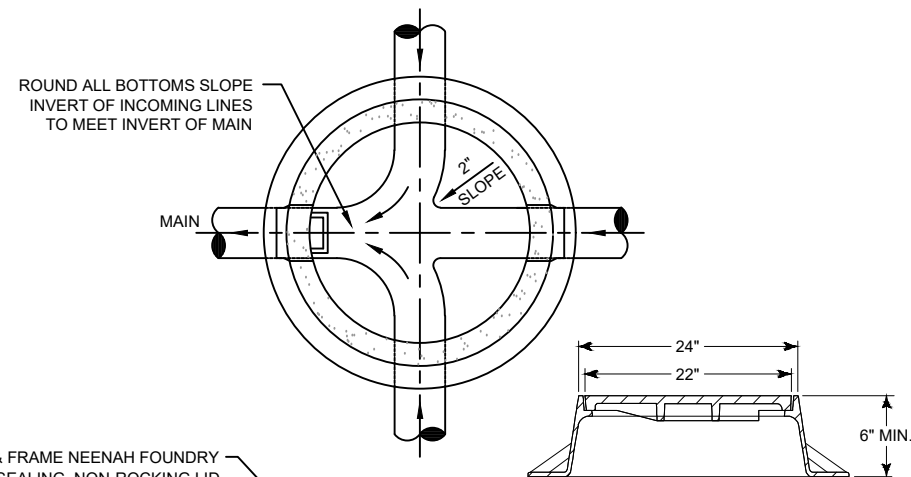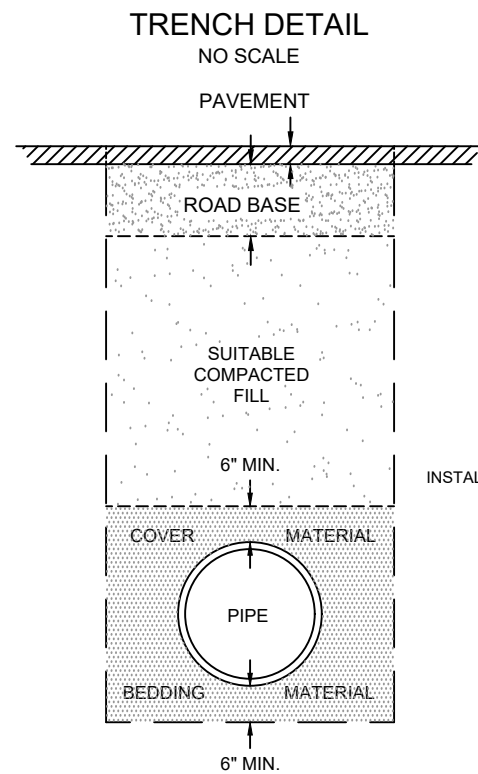

NO SCALE  
**STANDARD PRECAST SANITARY MANHOLE**

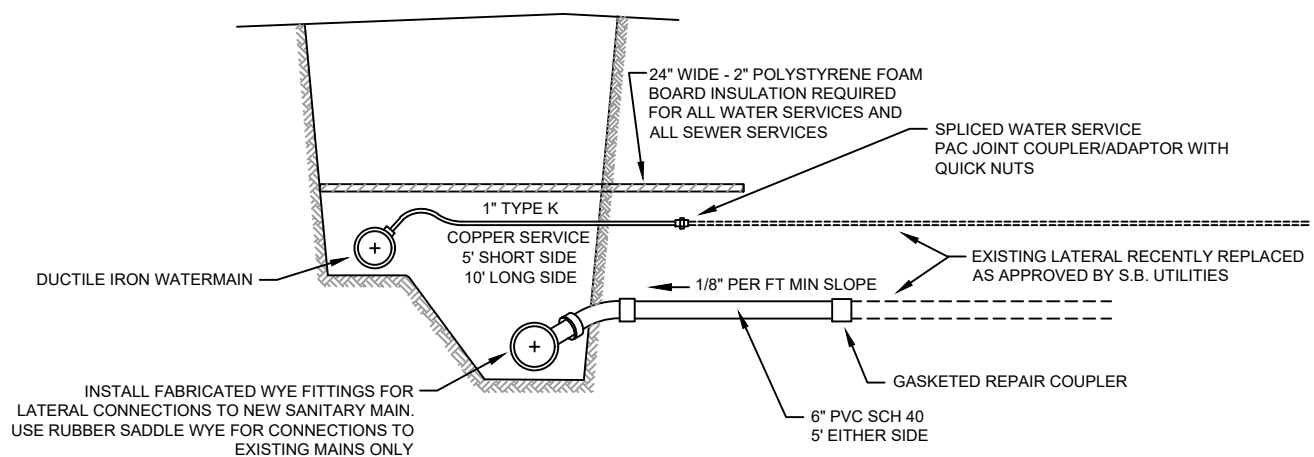

NO SCALE  
**TYPICAL SPLICED SANITARY & WATER SERVICE CONNECTION**

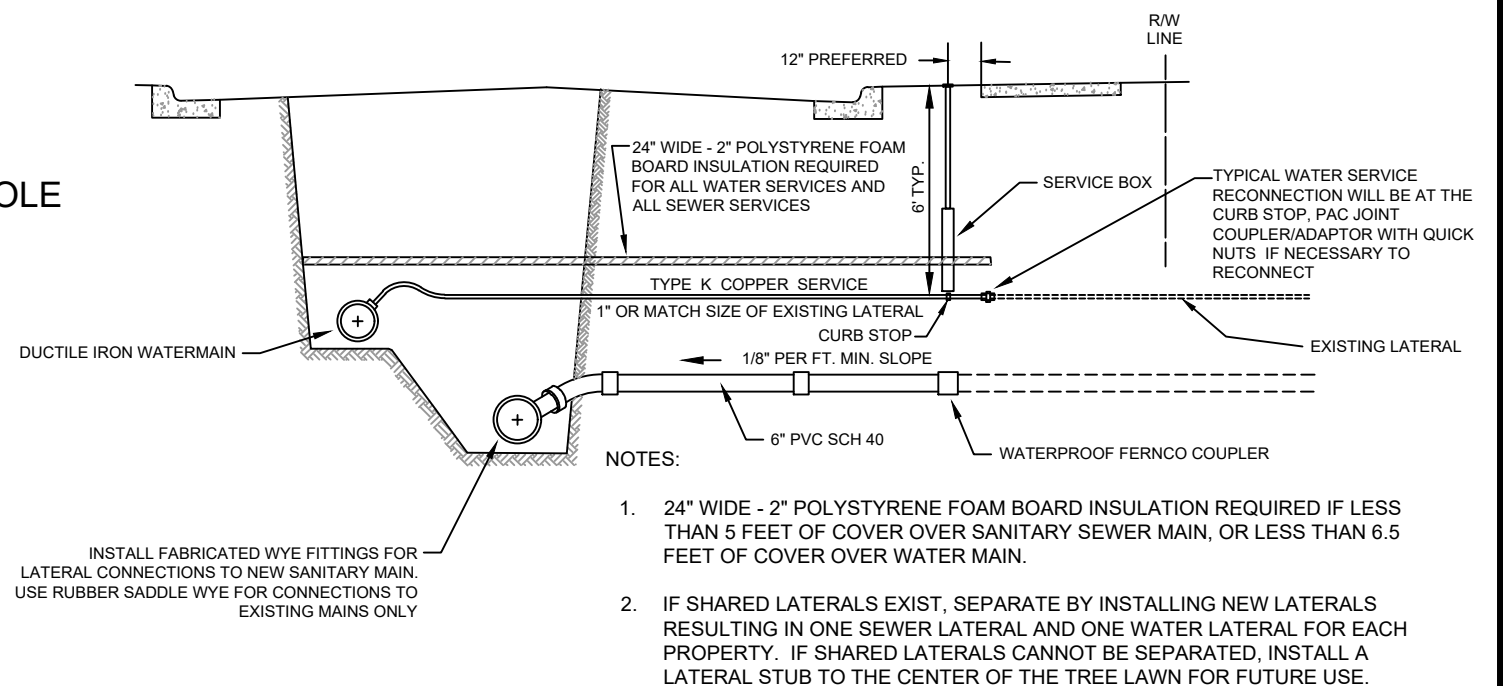

NO SCALE  
**TYPICAL NEW SANITARY & WATER SERVICE CONNECTION**

